




**POLYTECHNIC UNIVERSITY OF THE PHILIPPINES
COLLEGE OF ENGINEERING
COMPUTER ENGINEERING DEPARTMENT**




(02) 8713 5968 | dcoe_chair@gmail.com
RM322 CEA BLDG. NDC COMPOUND,
ANONAS COR. PUREZA STREETS, STA. MESA, MANILA

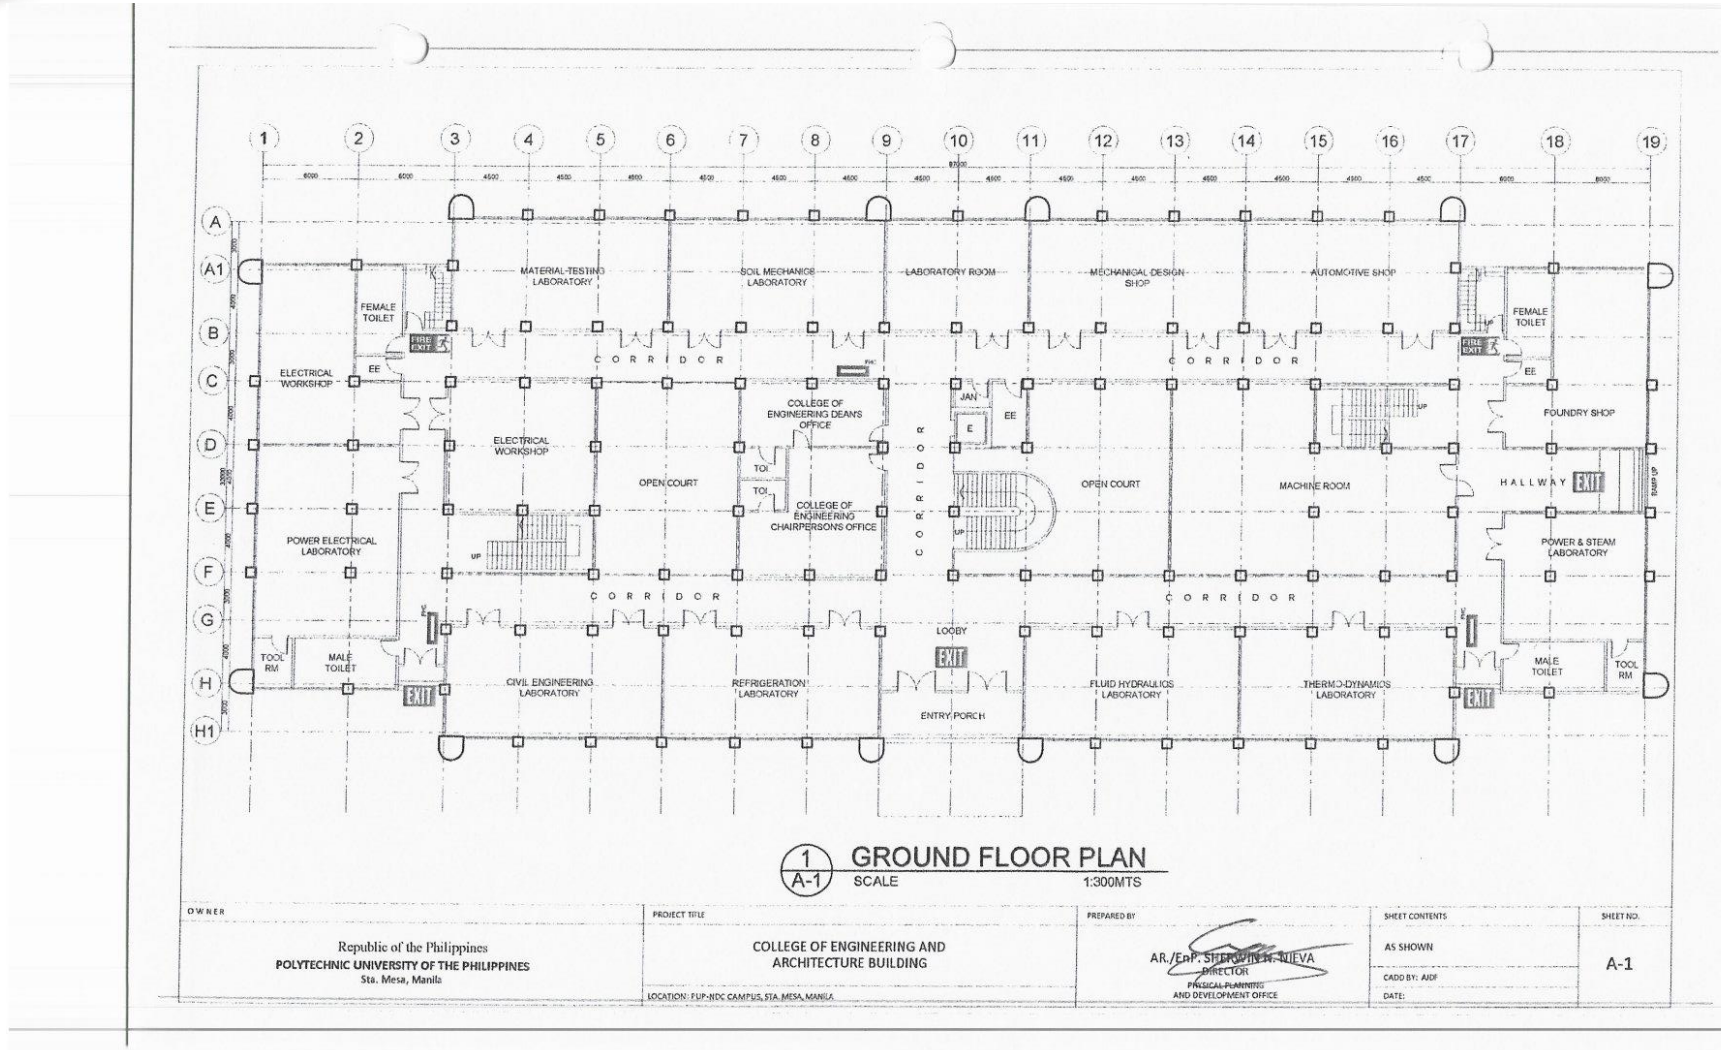



**POLYTECHNIC UNIVERSITY OF THE PHILIPPINES
COLLEGE OF ENGINEERING
COMPUTER ENGINEERING DEPARTMENT**

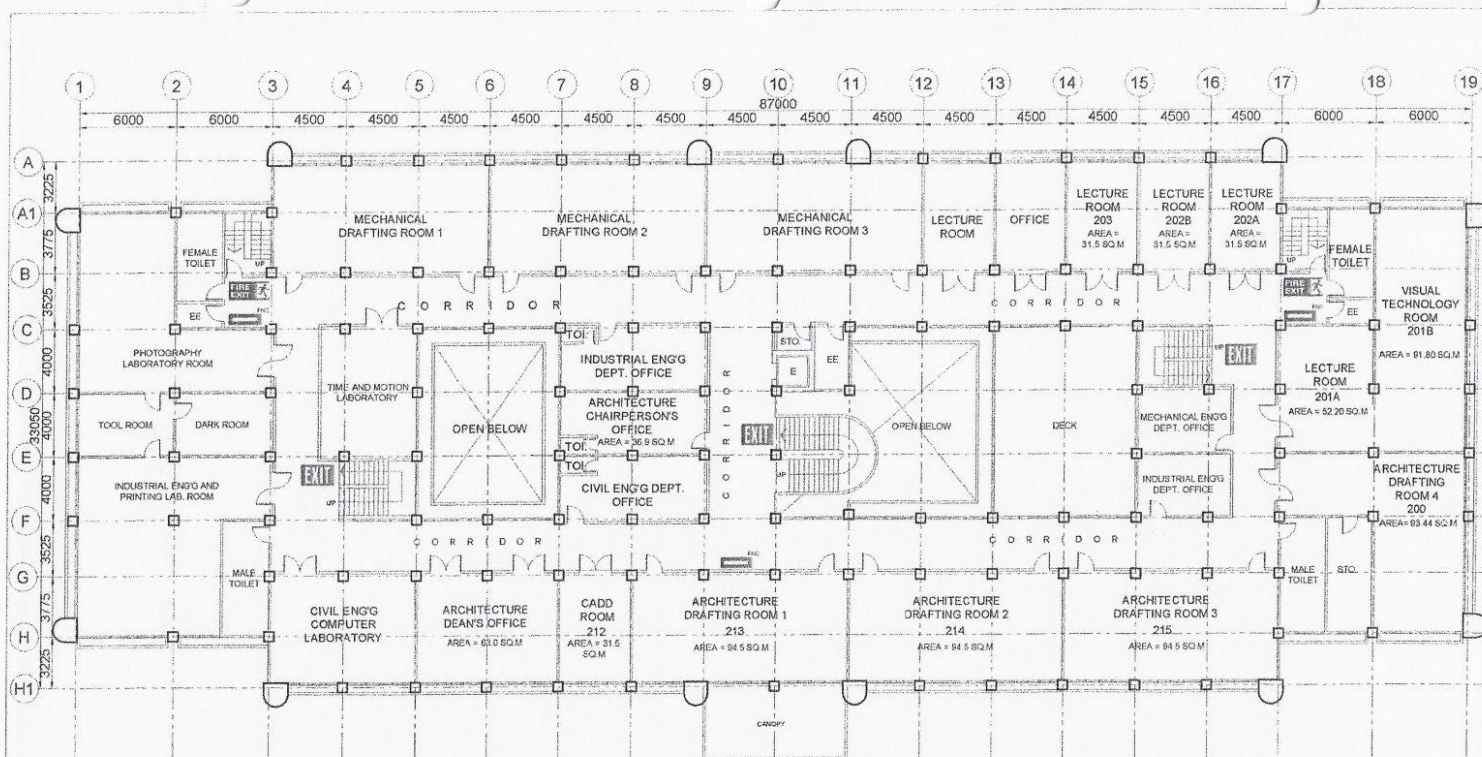

1
A-2 **SECOND FLOOR PLAN**
SCALE 1:300M/T


OWNER	PROJECT TITLE	PREPARED BY	SHEET CONTENTS	SHEET NO.
Republic of the Philippines POLYTECHNIC UNIVERSITY OF THE PHILIPPINES Sta. Mesa, Manila	COLLEGE OF ENGINEERING AND ARCHITECTURE BUILDING LOCATION: PUP-NDC CAMPUS, STA. MESA, MANILA	AB/ENR. SHERWIN D. NIEVA DIRECTOR PHYSICAL PLANNING AND DEVELOPMENT OFFICE	AS SHOWN CADD BY: ADF DATE:	A-2

(02) 8713 5968 | dcoe_chair@gmail.com
RM322 CEA BLDG. NDC COMPOUND,
ANONAS COR. PUREZA STREETS, STA. MESA, MANILA





**POLYTECHNIC UNIVERSITY OF THE PHILIPPINES
COLLEGE OF ENGINEERING
COMPUTER ENGINEERING DEPARTMENT**

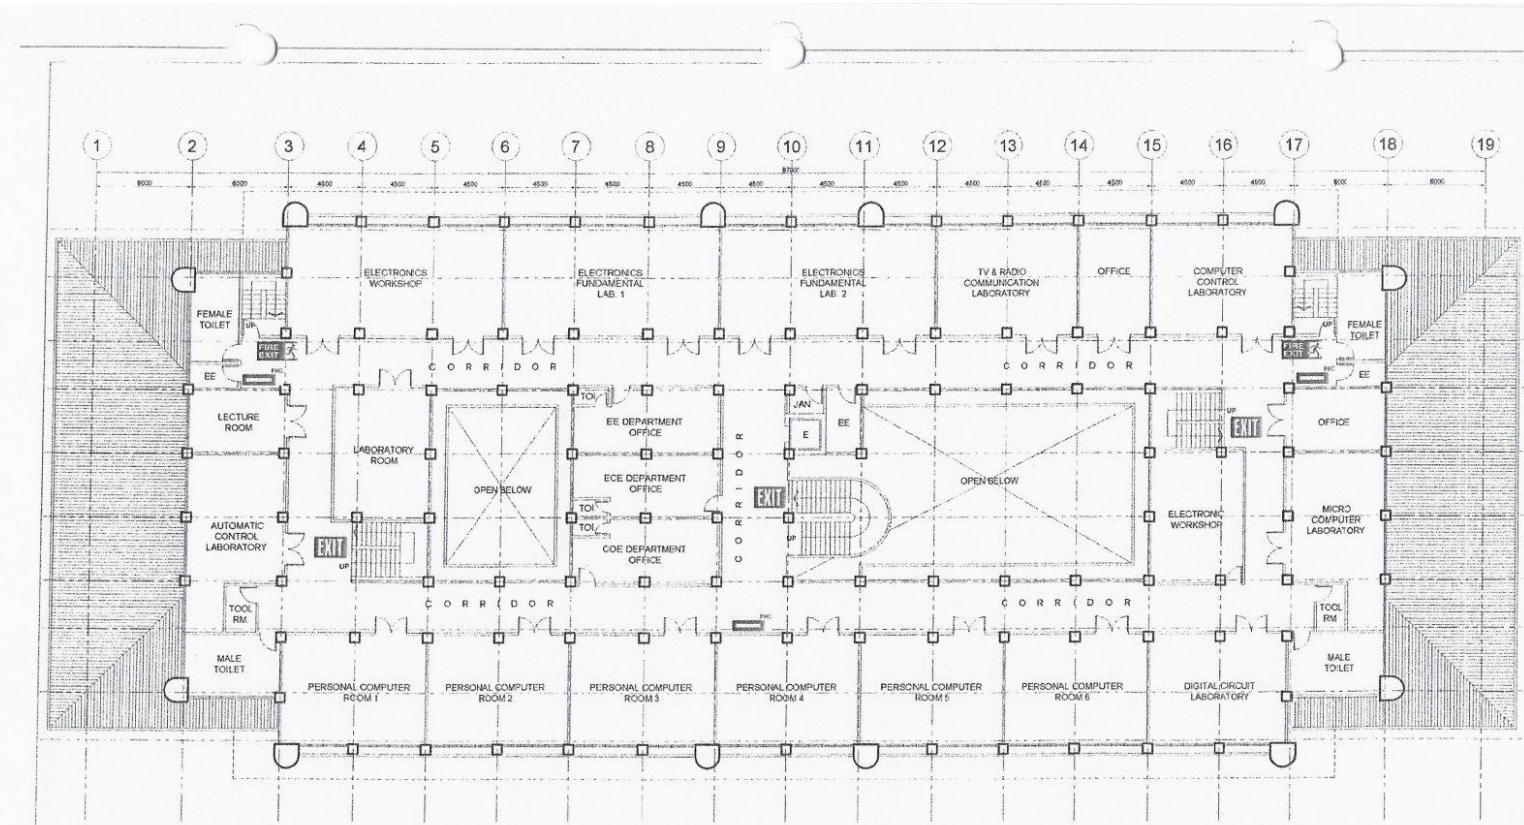

1 THIRD FLOOR PLAN
A-3 SCALE 1:300MTS


OWNER Republic of the Philippines POLYTECHNIC UNIVERSITY OF THE PHILIPPINES Sta. Mesa, Manila	PROJECT TITLE COLLEGE OF ENGINEERING AND ARCHITECTURE BUILDING LOCATION: PUP-NDC CAMPUS, STA. MESA, MANILA	PREPARED BY <i>AR. ENP. SHERWIN N. NIEMA</i> DIRECTOR PHYSICAL PLANNING AND DEVELOPMENT OFFICE	SHEET CONTENTS AS SHOWN CADD BY: ANP DATE:	SHEET NO. A-3
--	---	--	---	------------------

(02) 8713 5968 | dcoe_chair@gmail.com
RM322 CEA BLDG. NDC COMPOUND,
ANONAS COR. PUREZA STREETS, STA. MESA, MANILA





**POLYTECHNIC UNIVERSITY OF THE PHILIPPINES
COLLEGE OF ENGINEERING
COMPUTER ENGINEERING DEPARTMENT**

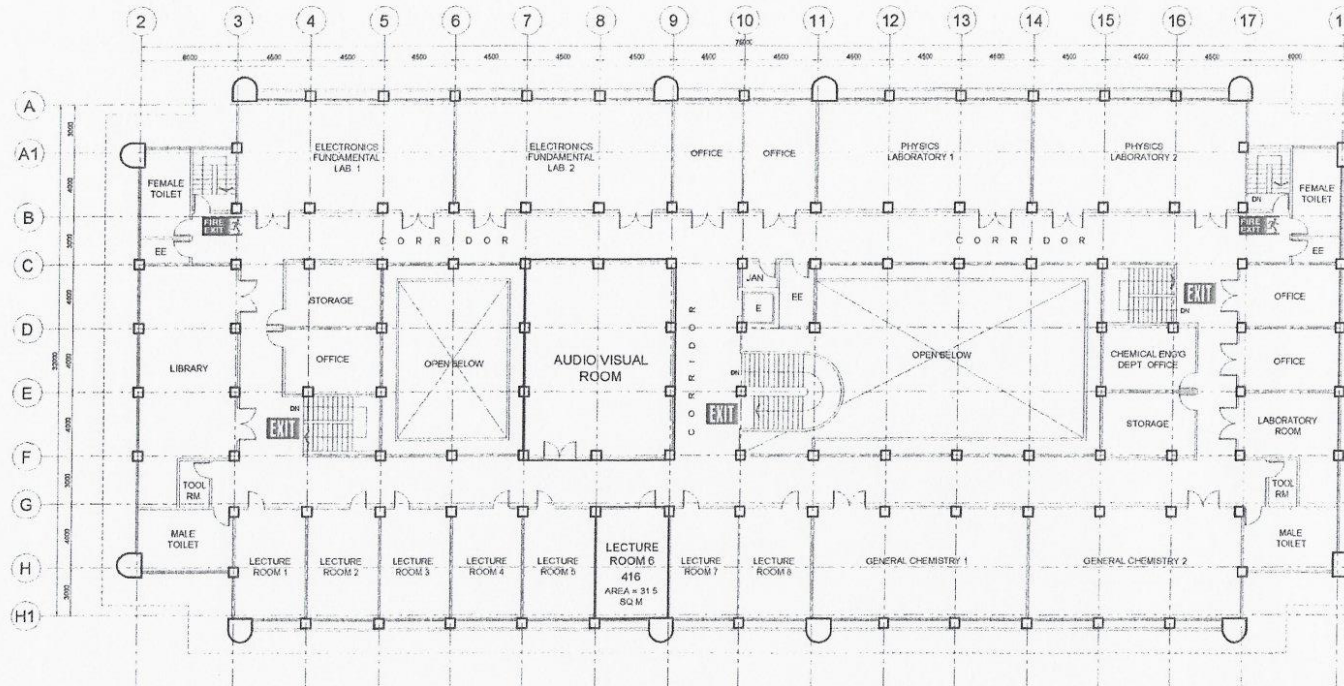

1
A-4 **FOURTH FLOOR PLAN**
SCALE 1:300MTS


OWNER Republic of the Philippines POLYTECHNIC UNIVERSITY OF THE PHILIPPINES Sta. Mesa, Manila	PROJECT TITLE COLLEGE OF ENGINEERING AND ARCHITECTURE BUILDING LOCATION: PUP-NDC CAMPUS, STA. MESA, MANILA	PREPARED BY AR./ENR. SHERWIN D. NIEVA DIRECTOR PLANNING, DESIGNING AND DEVELOPMENT OFFICE	SHEET CONTENTS AS SHOWN CADD BY: ARF DATE:	SHEET NO. A-4
--	---	---	---	------------------

(02) 8713 5968 | dcoe_chair@gmail.com
RM322 CEA BLDG. NDC COMPOUND,
ANONAS COR. PUREZA STREETS, STA. MESA, MANILA





POLYTECHNIC UNIVERSITY OF THE PHILIPPINES
COLLEGE OF ENGINEERING
COMPUTER ENGINEERING DEPARTMENT

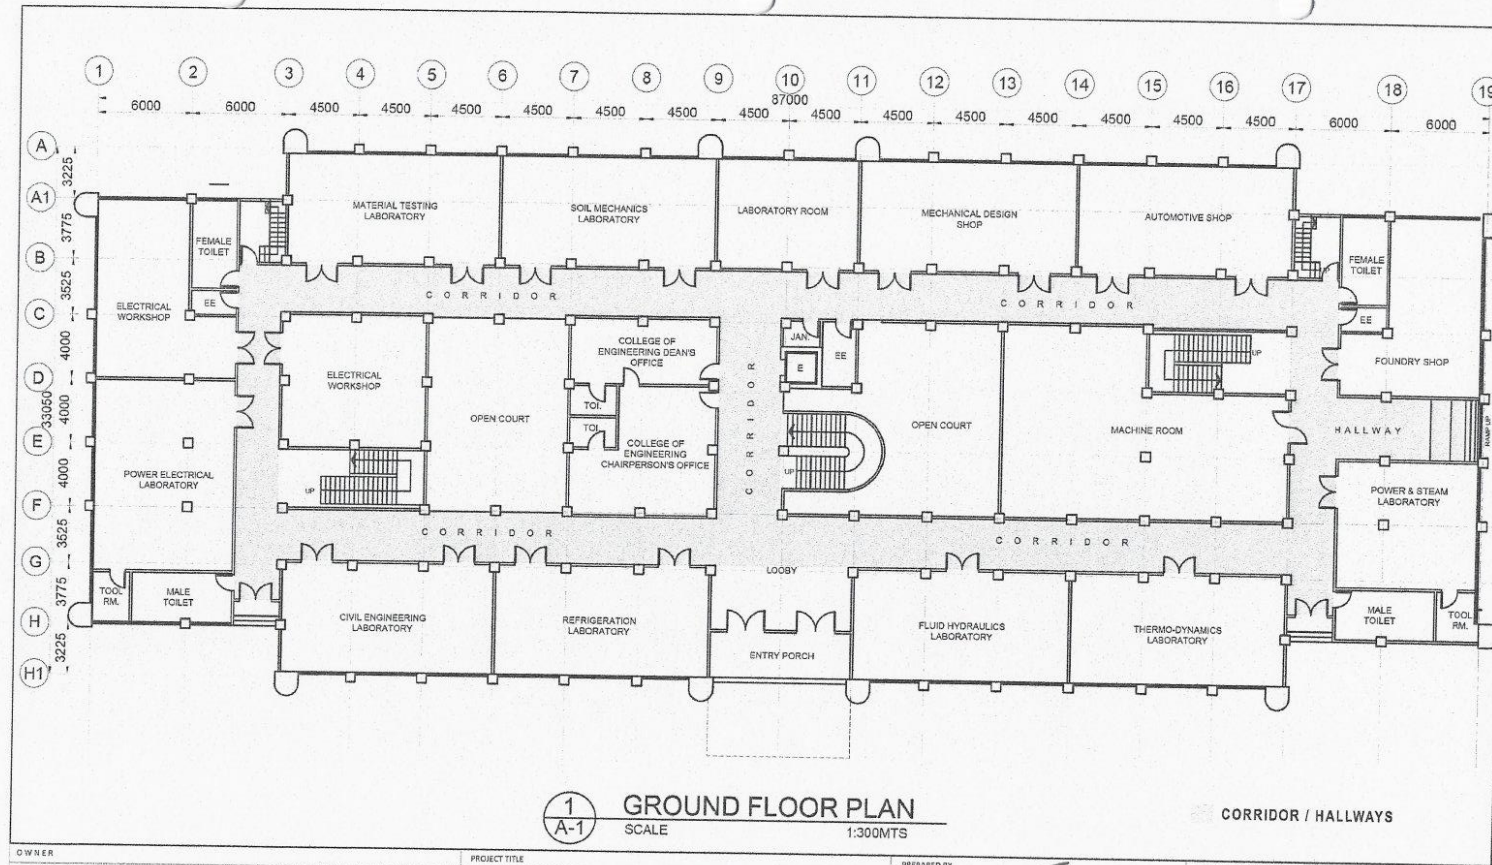

1
A-1
GROUND FLOOR PLAN
 SCALE 1:300MTS


OWNER	PROJECT TITLE	PREPARED BY	SHEET CONTENTS	SHEET NO.
Republic of the Philippines POLYTECHNIC UNIVERSITY OF THE PHILIPPINES Sta. Mesa, Manila	COLLEGE OF ENGINEERING AND ARCHITECTURE BUILDING LOCATION: PUP-NDC CAMPUS, STA. MESA, MANILA	AR. JEP. SHERWIN M. NIEVA DIRECTOR PHYSICAL PLANNING AND DEVELOPMENT OFFICE	AS SHOWN CADD BY: AIDF DATE: SEPTEMBER 2018	A-1

(02) 8713 5968 | dcoe_chair@gmail.com
 RM322 CEA BLDG. NDC COMPOUND,
 ANONAS COR. PUREZA STREETS, STA. MESA, MANILA





**POLYTECHNIC UNIVERSITY OF THE PHILIPPINES
COLLEGE OF ENGINEERING
COMPUTER ENGINEERING DEPARTMENT**

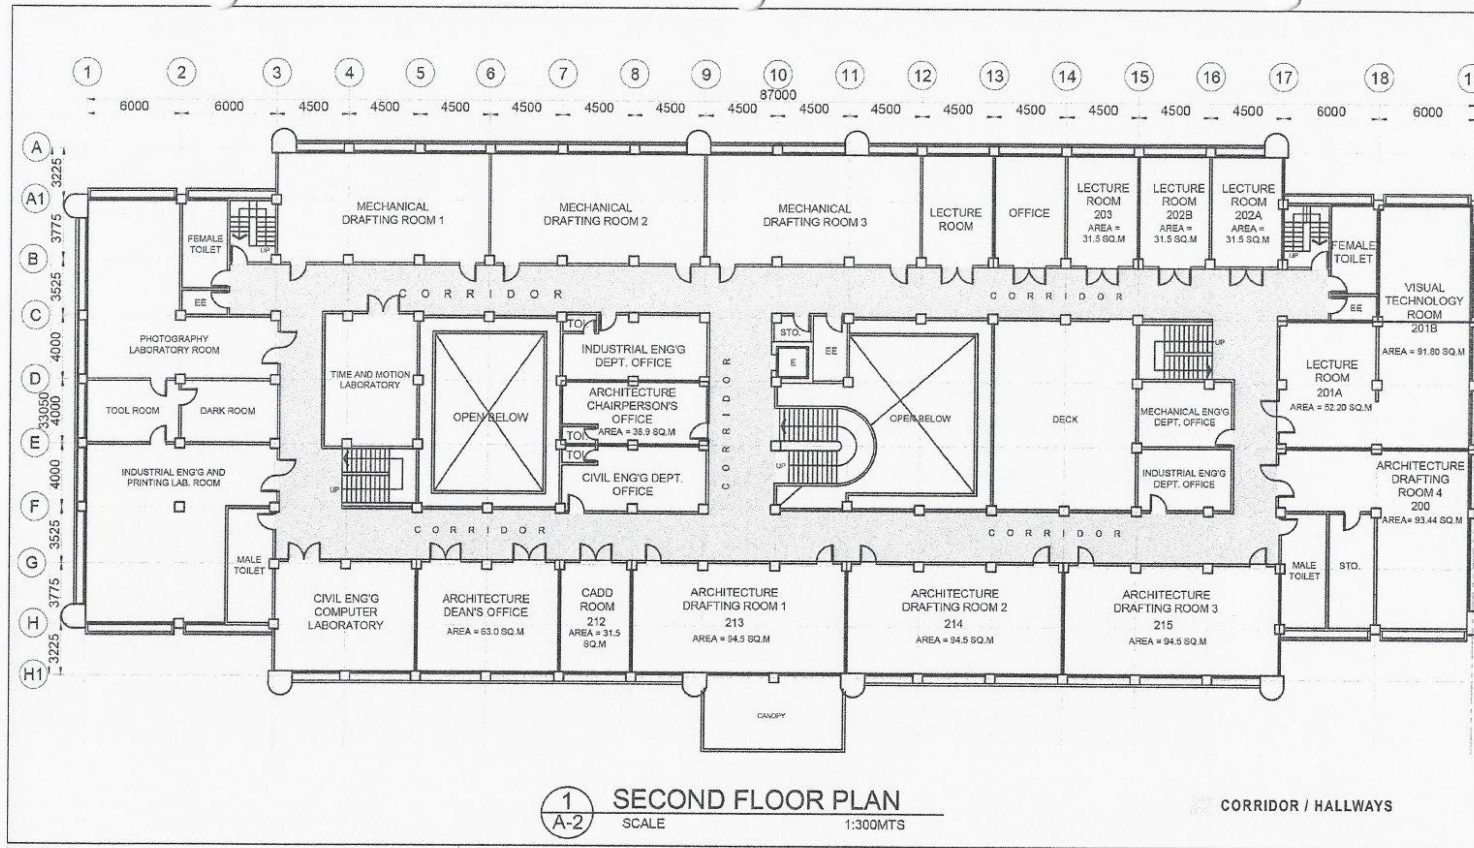


OWNER	PROJECT TITLE	PREPARED BY	SHEET CONTENTS	SHEET NO.
Republic of the Philippines POLYTECHNIC UNIVERSITY OF THE PHILIPPINES Sta. Mesa, Manila	COLLEGE OF ENGINEERING AND ARCHITECTURE BUILDING LOCATION: PUP-NDC CAMPUS, STA. MESA, MANILA	AR. ENP. SHERWIN N. NIEVA DIRECTOR PHYSICAL PLANNING AND DEVELOPMENT OFFICE	AS SHOWN CADD BY: AIDP DATE: SEPTEMBER 2018	A-2

(02) 8713 5968 | dcoe_chair@gmail.com
RM322 CEA BLDG. NDC COMPOUND,
ANONAS COR. PUREZA STREETS, STA. MESA, MANILA





POLYTECHNIC UNIVERSITY OF THE PHILIPPINES
COLLEGE OF ENGINEERING
COMPUTER ENGINEERING DEPARTMENT

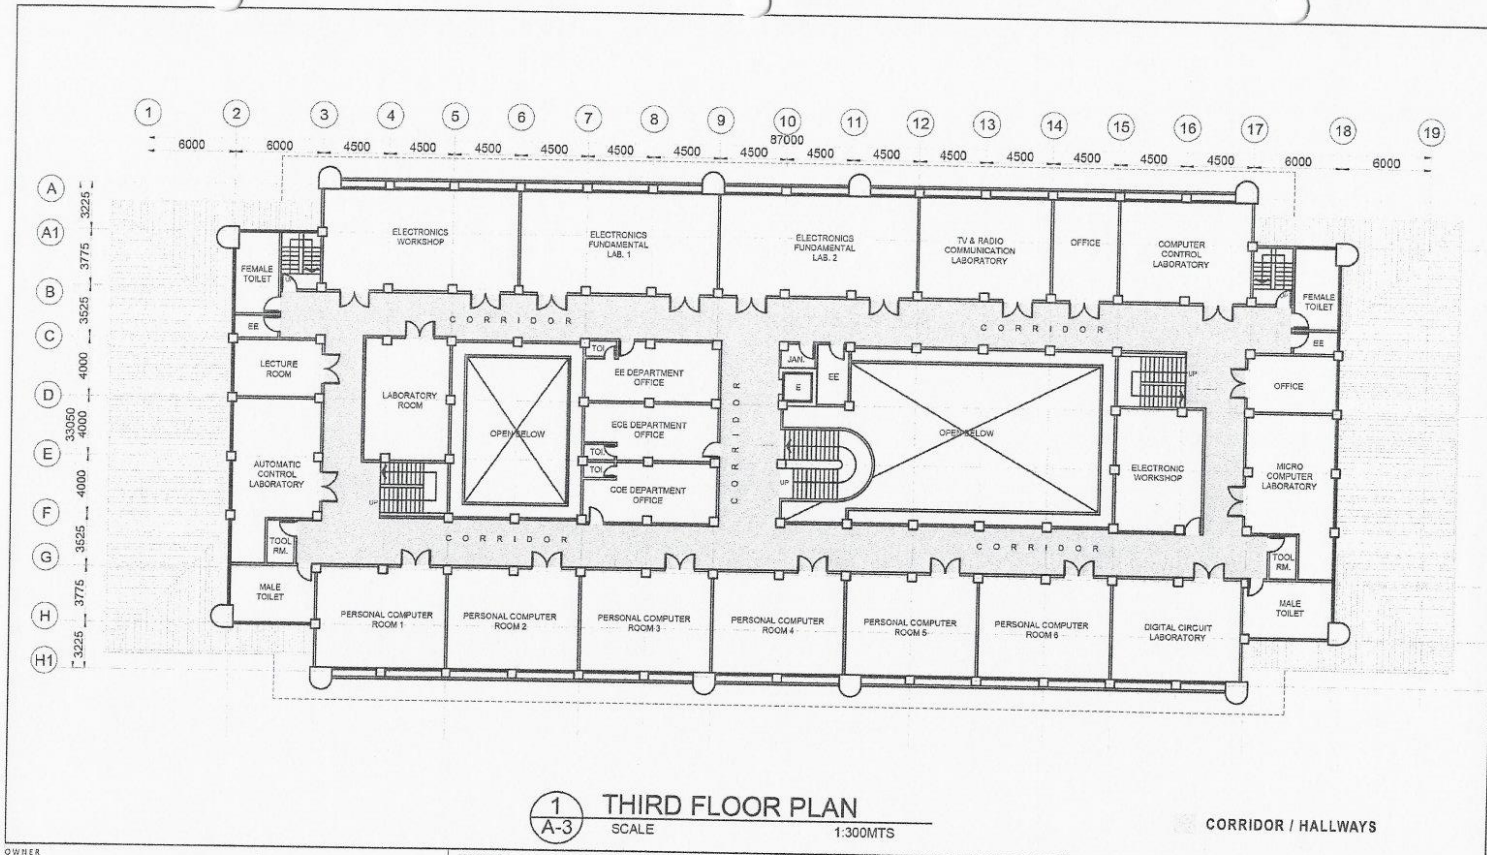


OWNER Republic of the Philippines POLYTECHNIC UNIVERSITY OF THE PHILIPPINES Sta. Mesa, Manila	PROJECT TITLE COLLEGE OF ENGINEERING AND ARCHITECTURE BUILDING LOCATION: PUP-NDC CAMPUS, STA. MESA, MANILA	PREPARED BY AR./ENR. SHERWIN N. NIEVA DIRECTOR PLANNING AND DEVELOPMENT OFFICE	SHEET CONTENTS AS SHOWN CADD BY: AIDF DATE: SEPTEMBER 2018	SHEET NO. A-3
--	--	---	---	------------------

(02) 8713 5968 | dcoe_chair@gmail.com
 RM322 CEA BLDG. NDC COMPOUND,
 ANONAS COR. PUREZA STREETS, STA. MESA, MANILA





**POLYTECHNIC UNIVERSITY OF THE PHILIPPINES
COLLEGE OF ENGINEERING
COMPUTER ENGINEERING DEPARTMENT**

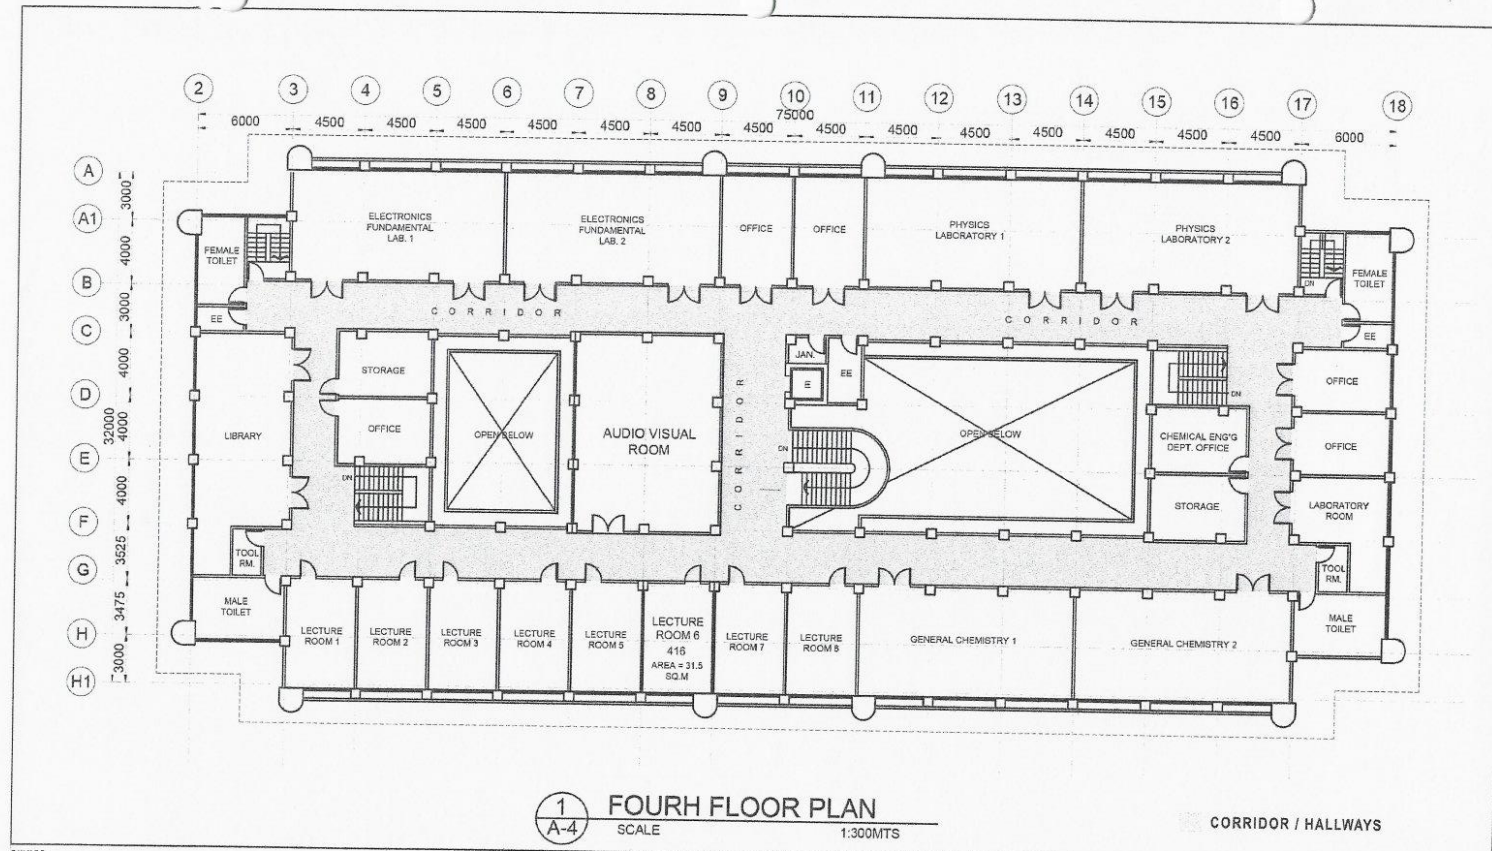


OWNER Republic of the Philippines POLYTECHNIC UNIVERSITY OF THE PHILIPPINES Sta. Mesa, Manila	PROJECT TITLE COLLEGE OF ENGINEERING AND ARCHITECTURE BUILDING LOCATION: PUP-NDC CAMPUS, STA. MESA, MANILA	PREPARED BY AR/ENR. SHERWIN D. NIEVA DIRECTOR PHYSICAL PLANNING AND DEVELOPMENT OFFICE	SHEET CONTENTS AS SHOWN CADD BY: AID DATE: SEPTEMBER 2018	SHEET NO. A-4
--	--	---	--	------------------

(02) 8713 5968 | dcoe_chair@gmail.com
RM322 CEA BLDG. NDC COMPOUND,
ANONAS COR. PUREZA STREETS, STA. MESA, MANILA





POLYTECHNIC UNIVERSITY OF THE PHILIPPINES
COLLEGE OF ENGINEERING
COMPUTER ENGINEERING DEPARTMENT

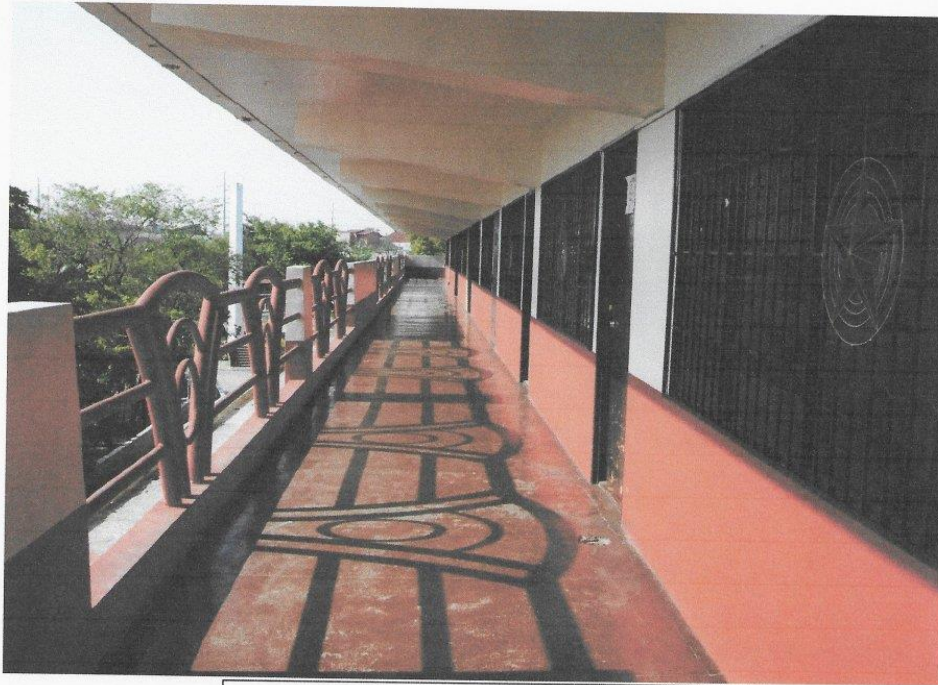

CORRIDOR AT MAIN BUILDING




CORRIDOR AT MAIN BUILDING



POLYTECHNIC UNIVERSITY OF THE PHILIPPINES
COLLEGE OF ENGINEERING
COMPUTER ENGINEERING DEPARTMENT



HALLWAY AT MAIN BUILDING

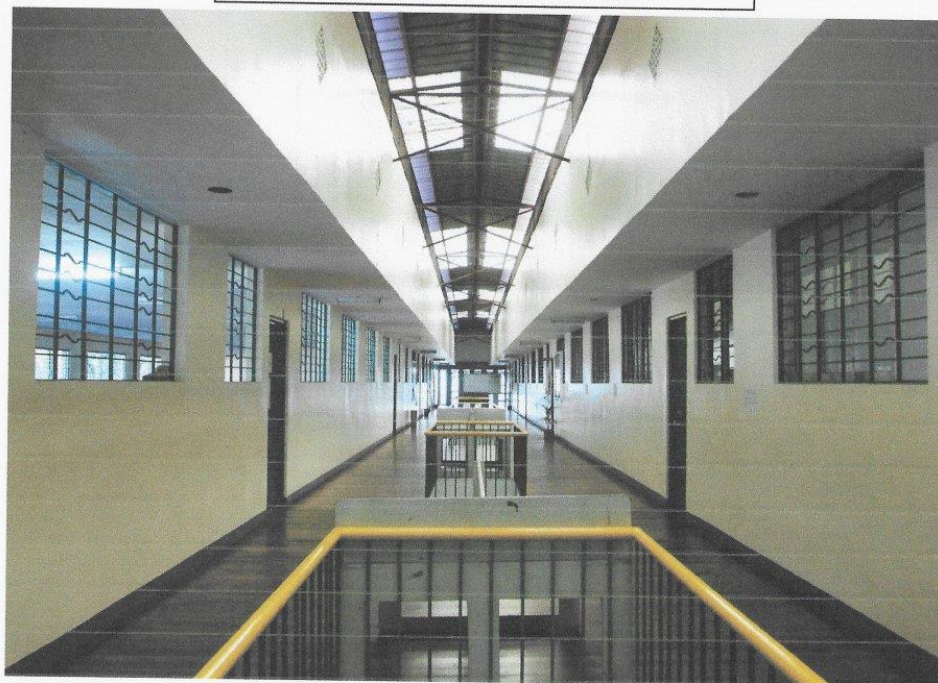

HALLWAY AT CHARLIE DEL ROSARIO