




POLYTECHNIC UNIVERSITY OF THE PHILIPPINES
 COLLEGE OF ENGINEERING
COMPUTER ENGINEERING DEPARTMENT

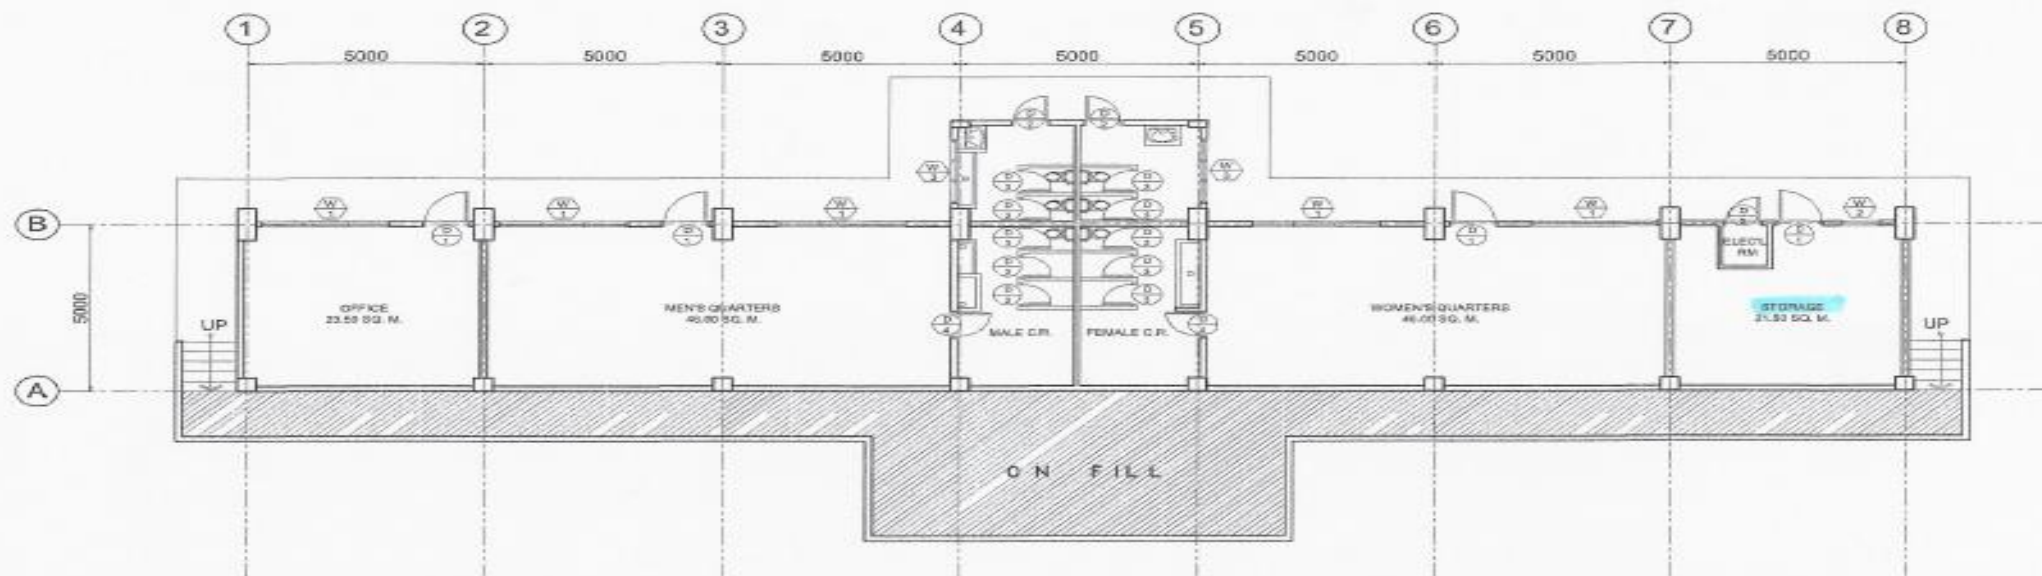

GROUND FLOOR PLAN
 SCALE 1:150 MTS

| | | | | |
|--|--|---|---|------------------|
| OWNER Republic of the Philippines POLYTECHNIC UNIVERSITY OF THE PHILIPPINES Sta. Mesa, Manila | PROJECT TITLE PUP TRACK OVAL GRANDSTAND LOCATION: MARINA CAMPUS, STA. MESA, MANILA | PREPARED BY <i>AR-ENG. STEPHEN M. MEWA</i> DIRECTOR PHYSICAL PLANNING AND DEVELOPMENT OFFICE | SHEET CONTENTS AS SHOWN CHECK BY: CD DATE: | SHEET NO. A-1 |
|--|--|---|---|------------------|


(02) 8713 5968 | dcoe_chair@gmail.com
 RM322 CEA BLDG. NDC COMPOUND,
 ANONAS COR. PUREZA STREETS, STA. MESA, MANILA



ISO 9001:2015 CERTIFIED
 CERTIFICATE NUMBER: SCP0004130



POLYTECHNIC UNIVERSITY OF THE PHILIPPINES
 COLLEGE OF ENGINEERING
COMPUTER ENGINEERING DEPARTMENT

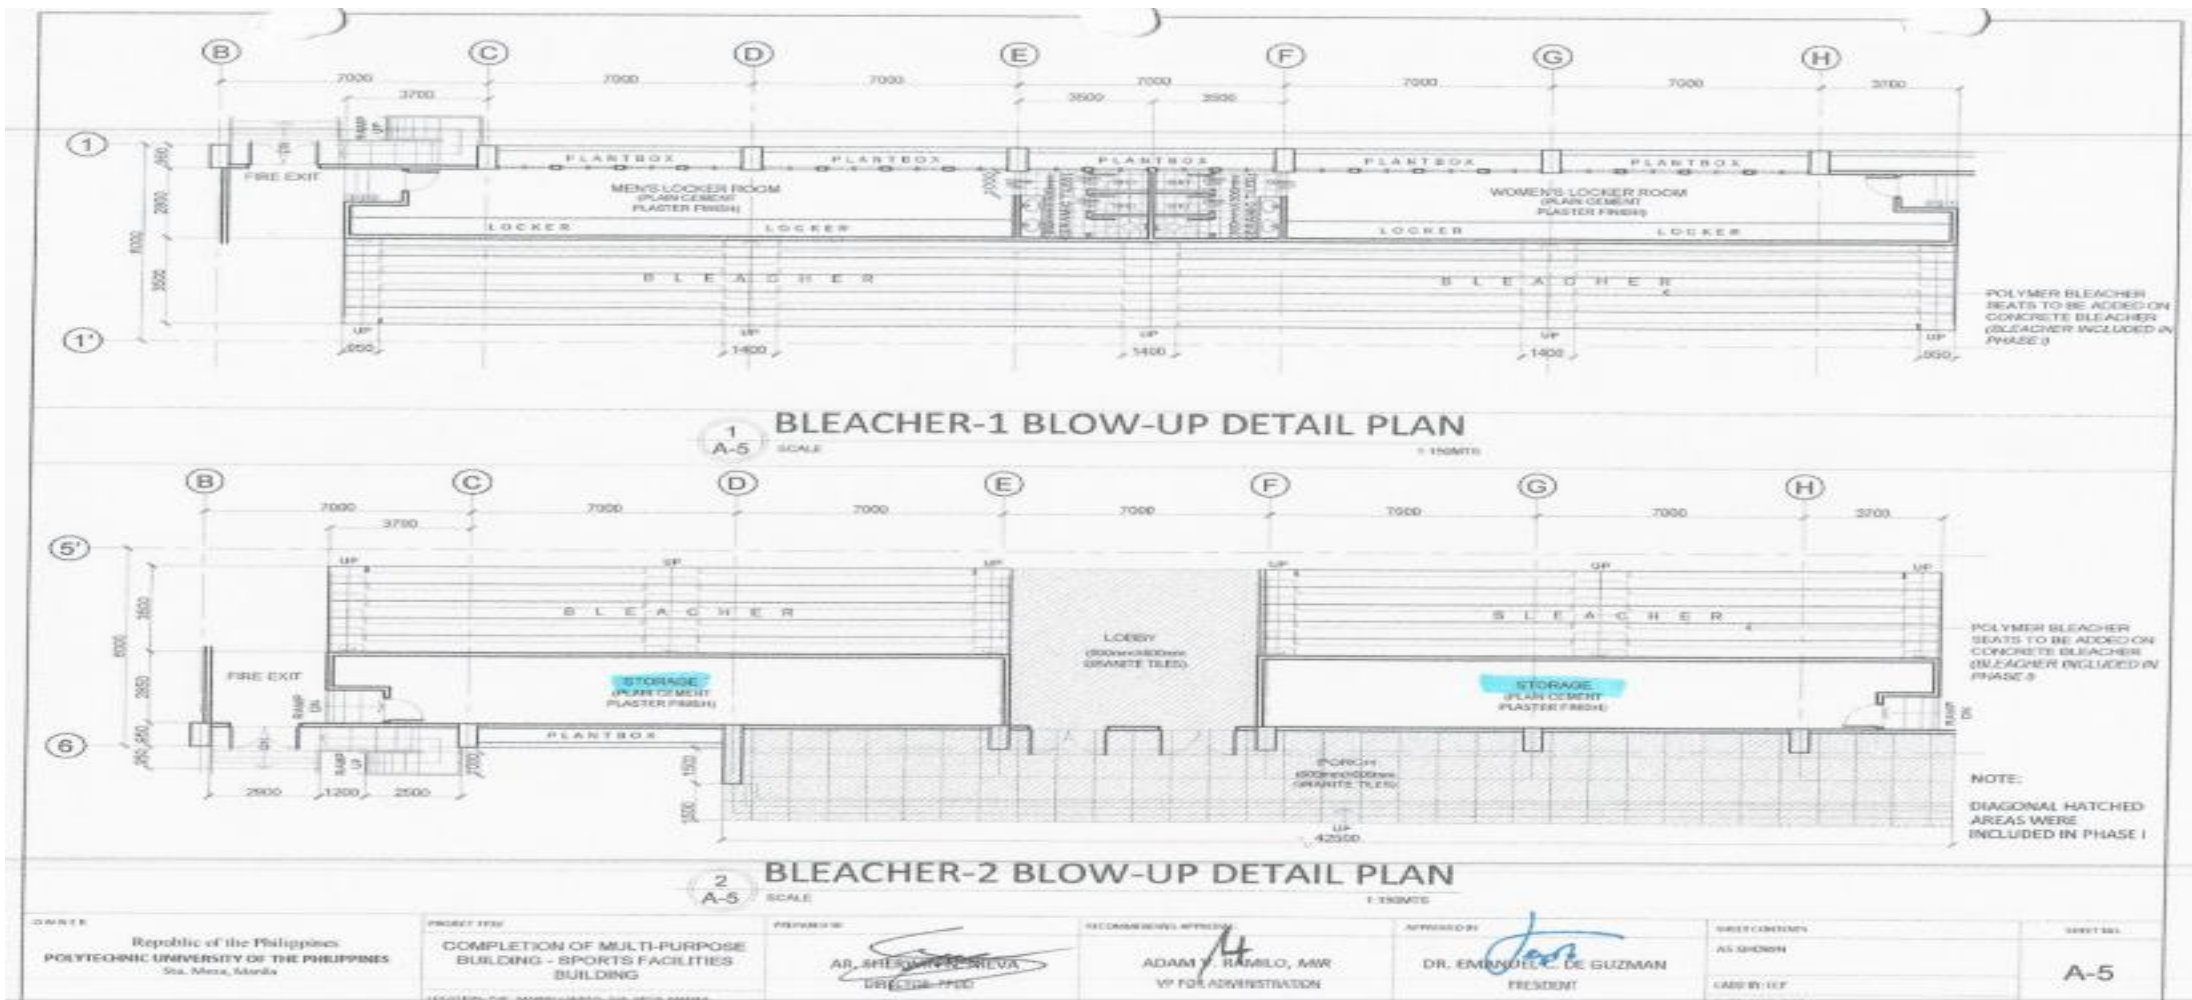


(02) 8713 5968 | dcoe_chair@gmail.com
 RM322 CEA BLDG. NDC COMPOUND,
 ANONAS COR. PUREZA STREETS, STA. MESA, MANILA






POLYTECHNIC UNIVERSITY OF THE PHILIPPINES
 COLLEGE OF ENGINEERING
COMPUTER ENGINEERING DEPARTMENT

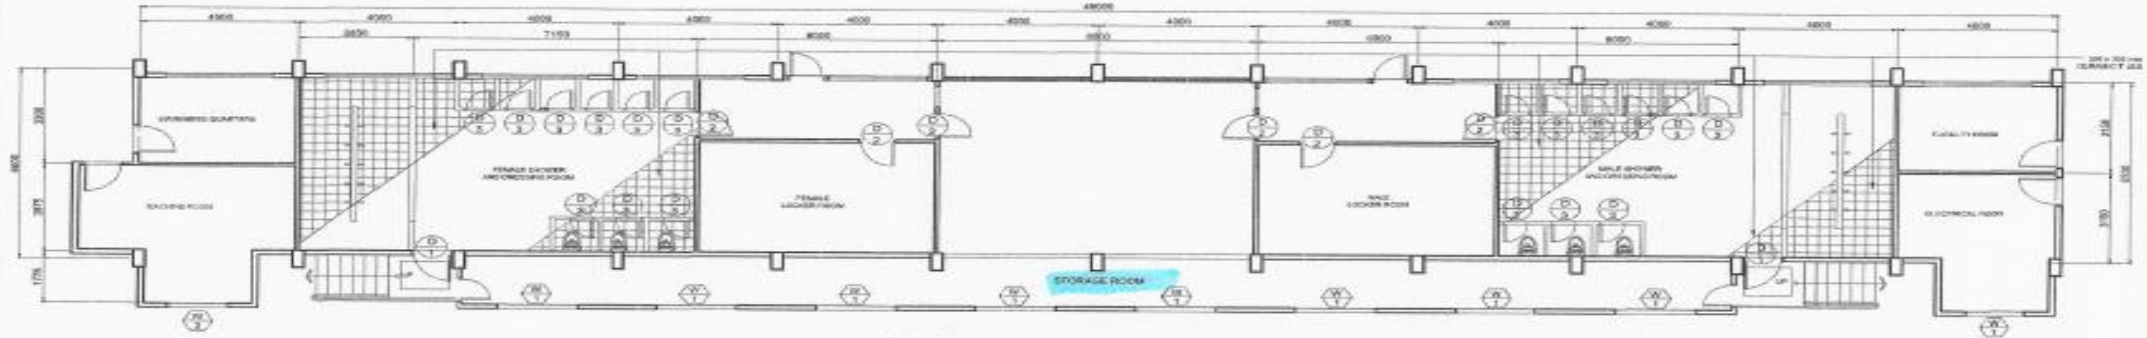

GROUND FLOOR PLAN
 SCALE 1:150 MTS

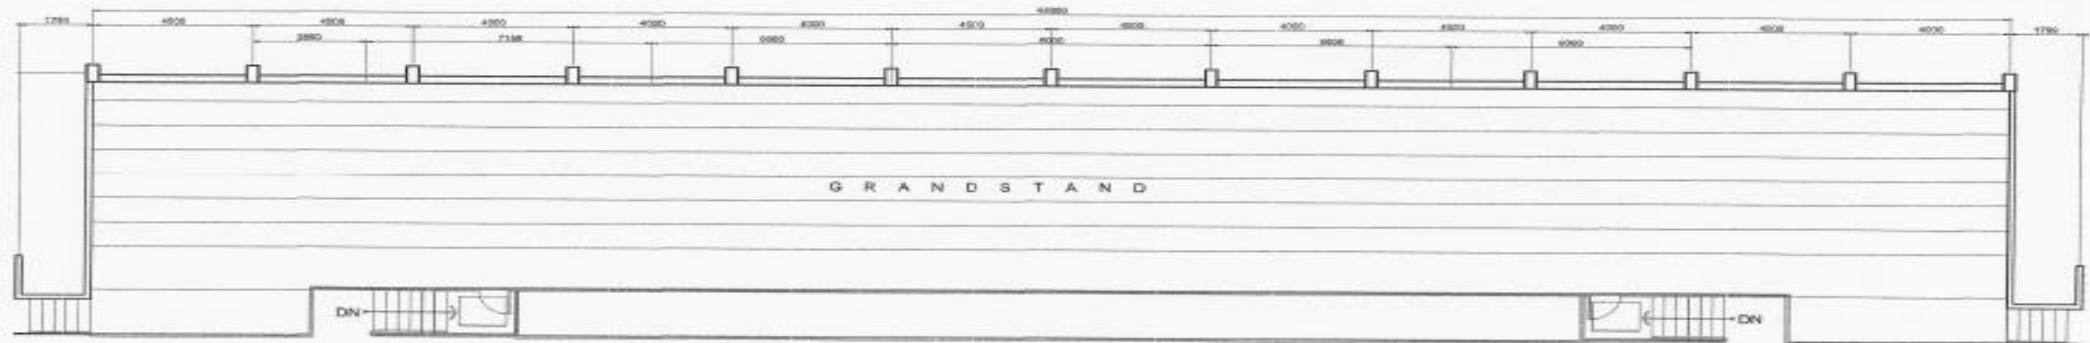

SECOND FLOOR PLAN
 SCALE 1:150 MTS

| | | | | |
|---|---------------------------------|--|-----------------------------------|-----------|
| OWNER | PROJECT TITLE | PREPARED BY | SHEET CONTENTS | SHEET NO. |
| Republic of the Philippines POLYTECHNIC UNIVERSITY OF THE PHILIPPINES Sta. Mesa, Manila | PUP SWIMMING POOL GRANDSTAND | AB-YEN SHERWIN N. NIEVA DIRECTOR PHYSICAL PLANNING AND DEVELOPMENT OFFICE | AS SHOWN CADD BY: COP DATE: | A-1 |
| LOCATION: MADRI CAMPUS, STA. MESA, MANILA | | | | |

(02) 8713 5968 | dcoe_chair@gmail.com
 RM322 CEA BLDG. NDC COMPOUND,
 ANONAS COR. PUREZA STREETS, STA. MESA, MANILA





POLYTECHNIC UNIVERSITY OF THE PHILIPPINES
COLLEGE OF ENGINEERING
COMPUTER ENGINEERING DEPARTMENT



SPORTS EQUIPMENT
(Use for training in various sports)



POLYTECHNIC UNIVERSITY OF THE PHILIPPINES
COLLEGE OF ENGINEERING
COMPUTER ENGINEERING DEPARTMENT



SPORTS EQUIPMENT
(Use for training in various sports)



POLYTECHNIC UNIVERSITY OF THE PHILIPPINES
COLLEGE OF ENGINEERING
COMPUTER ENGINEERING DEPARTMENT



SPORTS EQUIPMENT
(Use for training in various sports)