




**POLYTECHNIC UNIVERSITY OF THE PHILIPPINES
COLLEGE OF ENGINEERING
COMPUTER ENGINEERING DEPARTMENT**

GROUND FLOOR PLAN
SCALE 1:400 M1S

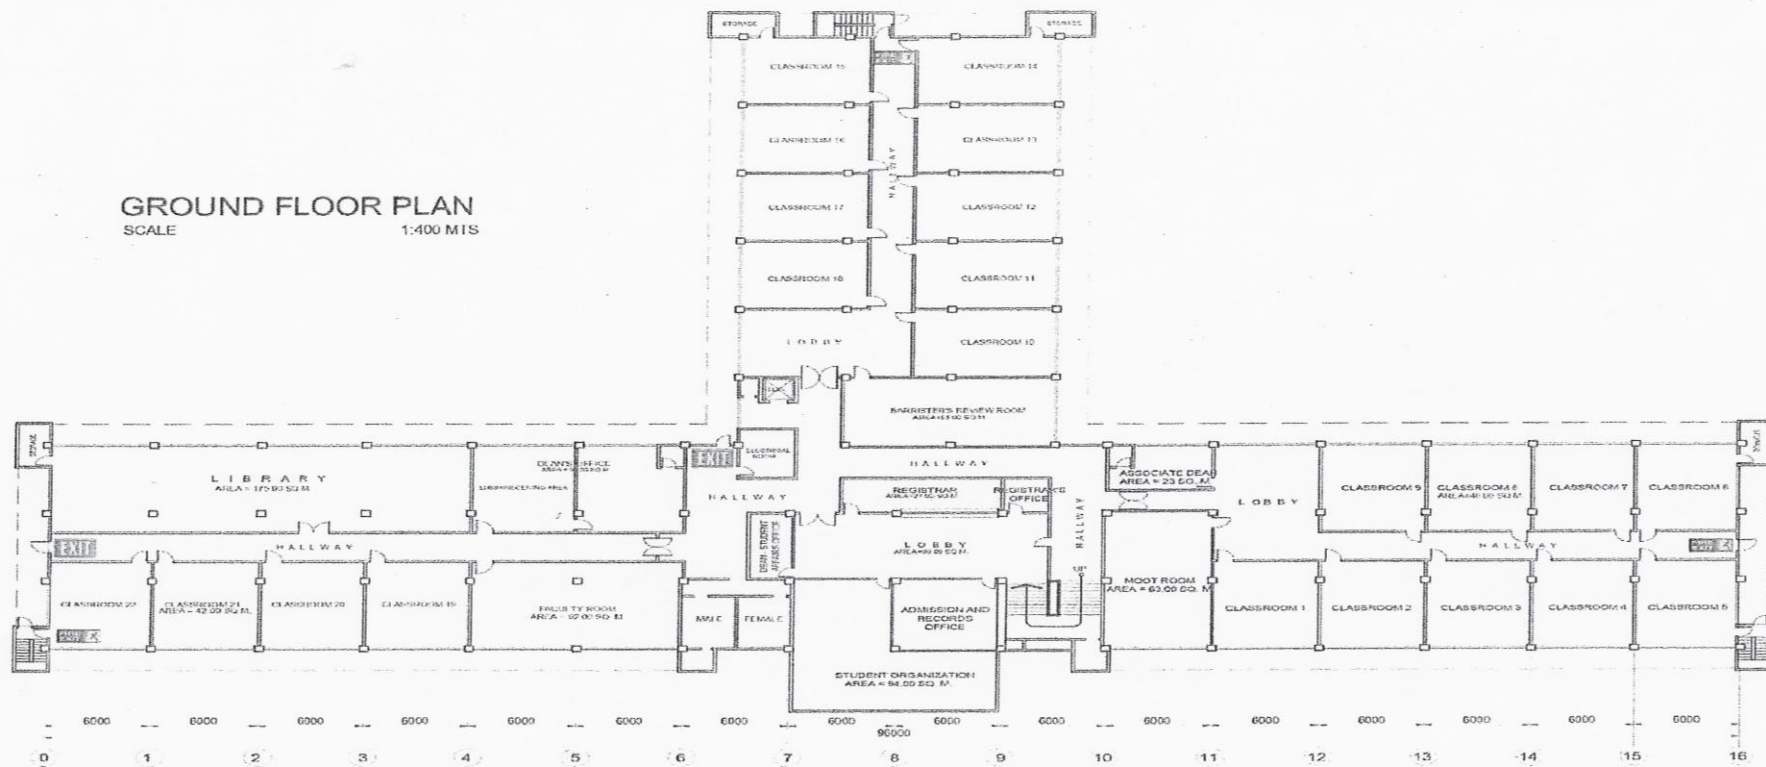


OWNER	PROJECT TITLE	PREPARED BY	SHEET CONTENTS	SHEET NO.
Republic of the Philippines POLYTECHNIC UNIVERSITY OF THE PHILIPPINES Sta. Mesa, Manila	NINYO AQUINO LEARNING RESOURCE CENTER LOCATION: PUP-MABINI CAMPUS, STA. MESA, MANILA	AR./ENR. SHERWIN S. NIEVA DIRECTOR PHYSICAL PLANNING AND DEVELOPMENT OFFICE	AS SHOWN CADD BY: CCP DATE:	A-1

(02) 8713 5968 | dcoe_chair@gmail.com
RM322 CEA BLDG. NDC COMPOUND,
ANONAS COR. PUREZA STREETS, STA. MESA, MANILA





POLYTECHNIC UNIVERSITY OF THE PHILIPPINES
 COLLEGE OF ENGINEERING
COMPUTER ENGINEERING DEPARTMENT

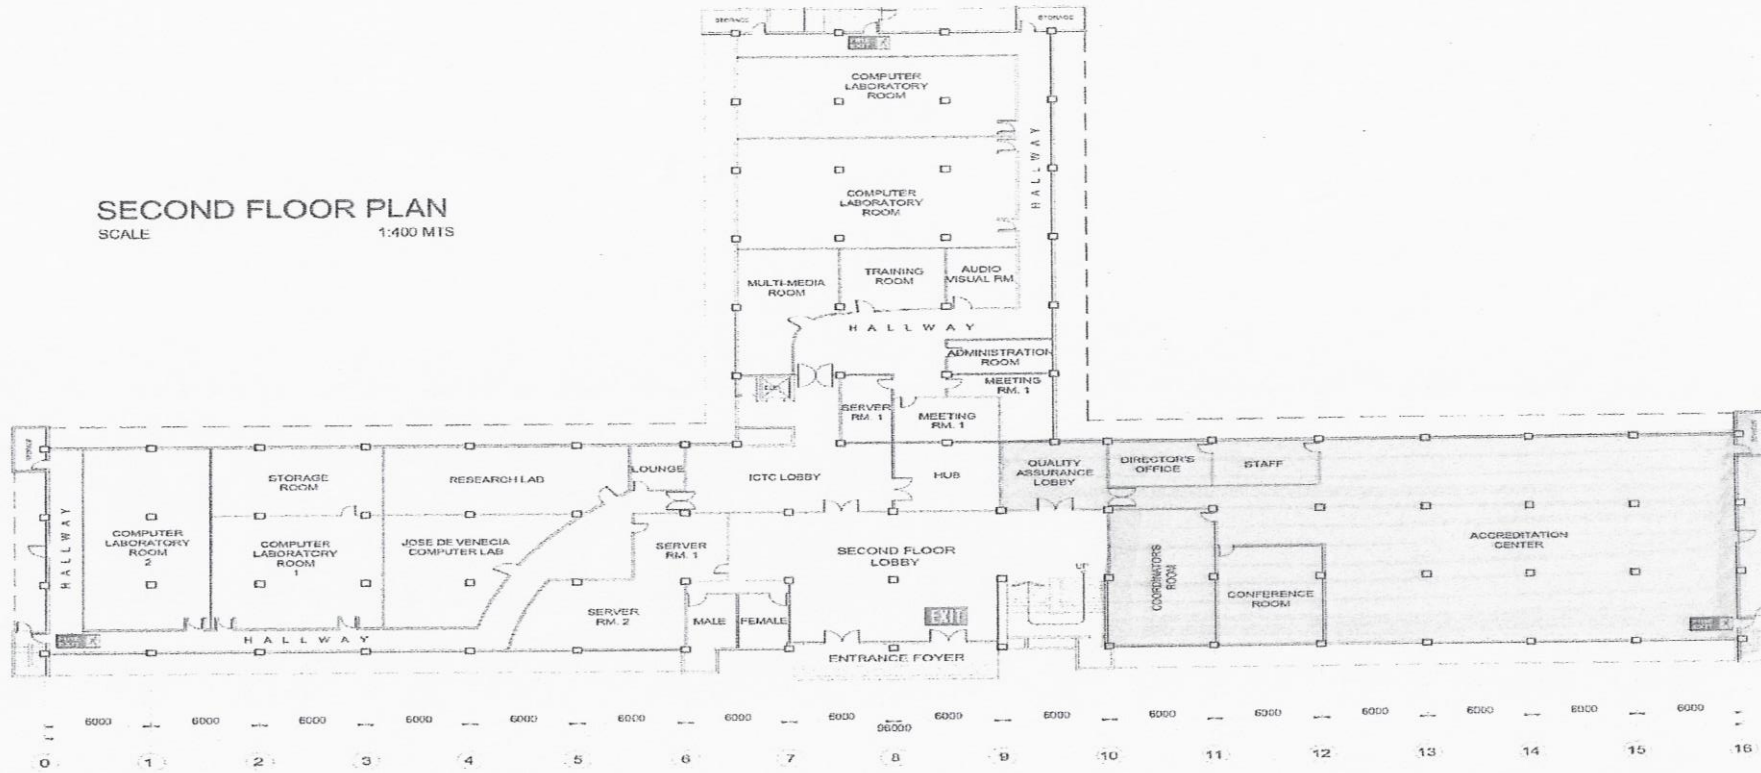

SECOND FLOOR PLAN
 SCALE 1:400 MTS


OWNER Republic of the Philippines POLYTECHNIC UNIVERSITY OF THE PHILIPPINES Sta. Mesa, Manila	PROJECT TITLE NINYO AQUINO LEARNING RESOURCE CENTER LOCATION: PUP MABINI CAMPUS, STA. MESA, MANILA	PREPARED BY AR. ENR. SHERWIN NIEVA DIRECTOR DESIGN, PLANNING AND DEVELOPMENT OFFICE	SHEET CONTENTS AS SHOWN CADD BY: CCP DATE:	SHEET NO A-2
--	--	--	---	-----------------

(02) 8713 5968 | dcoe_chair@gmail.com
 RM322 CEA BLDG. NDC COMPOUND,
 ANONAS COR. PUREZA STREETS, STA. MESA, MANILA





POLYTECHNIC UNIVERSITY OF THE PHILIPPINES
 COLLEGE OF ENGINEERING
COMPUTER ENGINEERING DEPARTMENT

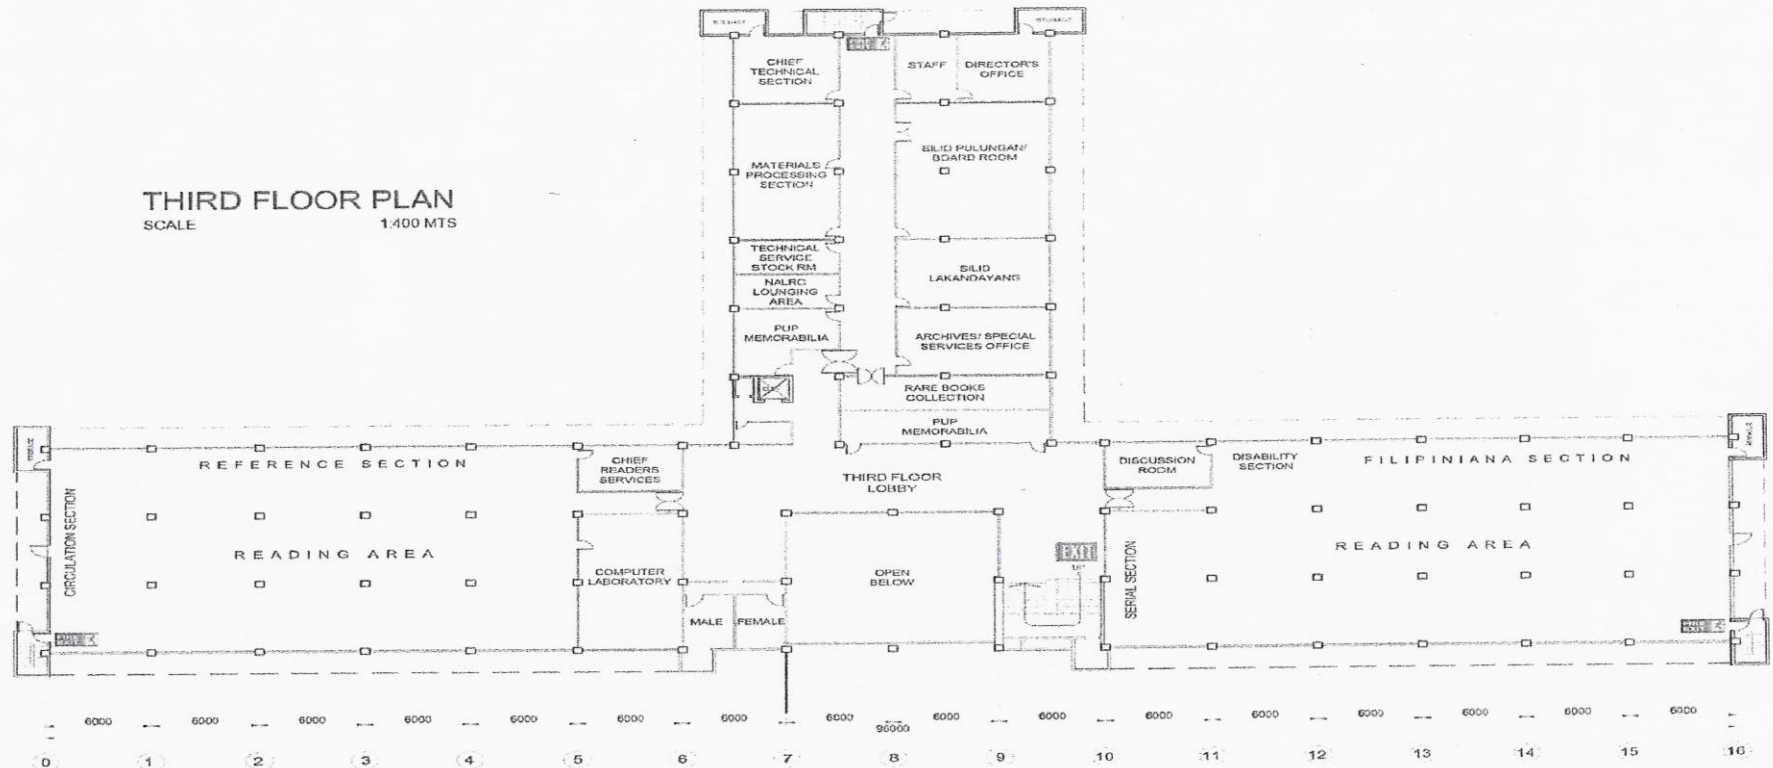

OWNER	PROJECT TITLE	PREPARED BY	SHEET CONTENTS	SHEET NO.
Republic of the Philippines POLYTECHNIC UNIVERSITY OF THE PHILIPPINES Sta. Mesa, Manila	NINYO AQUINO LEARNING RESOURCE CENTER LOCATION: PUP-MABINI CAMPUS, STA. MESA, MANILA	AR. JERP. SIERWIN N. NIEVA DIRECTOR PHYSICAL PLANNING AND DEVELOPMENT OFFICE	AS SHOWN CADD BY: CCP DATE:	A-3


(02) 8713 5968 | dcoe_chair@gmail.com
 RM322 CEA BLDG. NDC COMPOUND,
 ANONAS COR. PUREZA STREETS, STA. MESA, MANILA





**POLYTECHNIC UNIVERSITY OF THE PHILIPPINES
COLLEGE OF ENGINEERING
COMPUTER ENGINEERING DEPARTMENT**

FOURTH FLOOR PLAN
SCALE 1:400 M1S

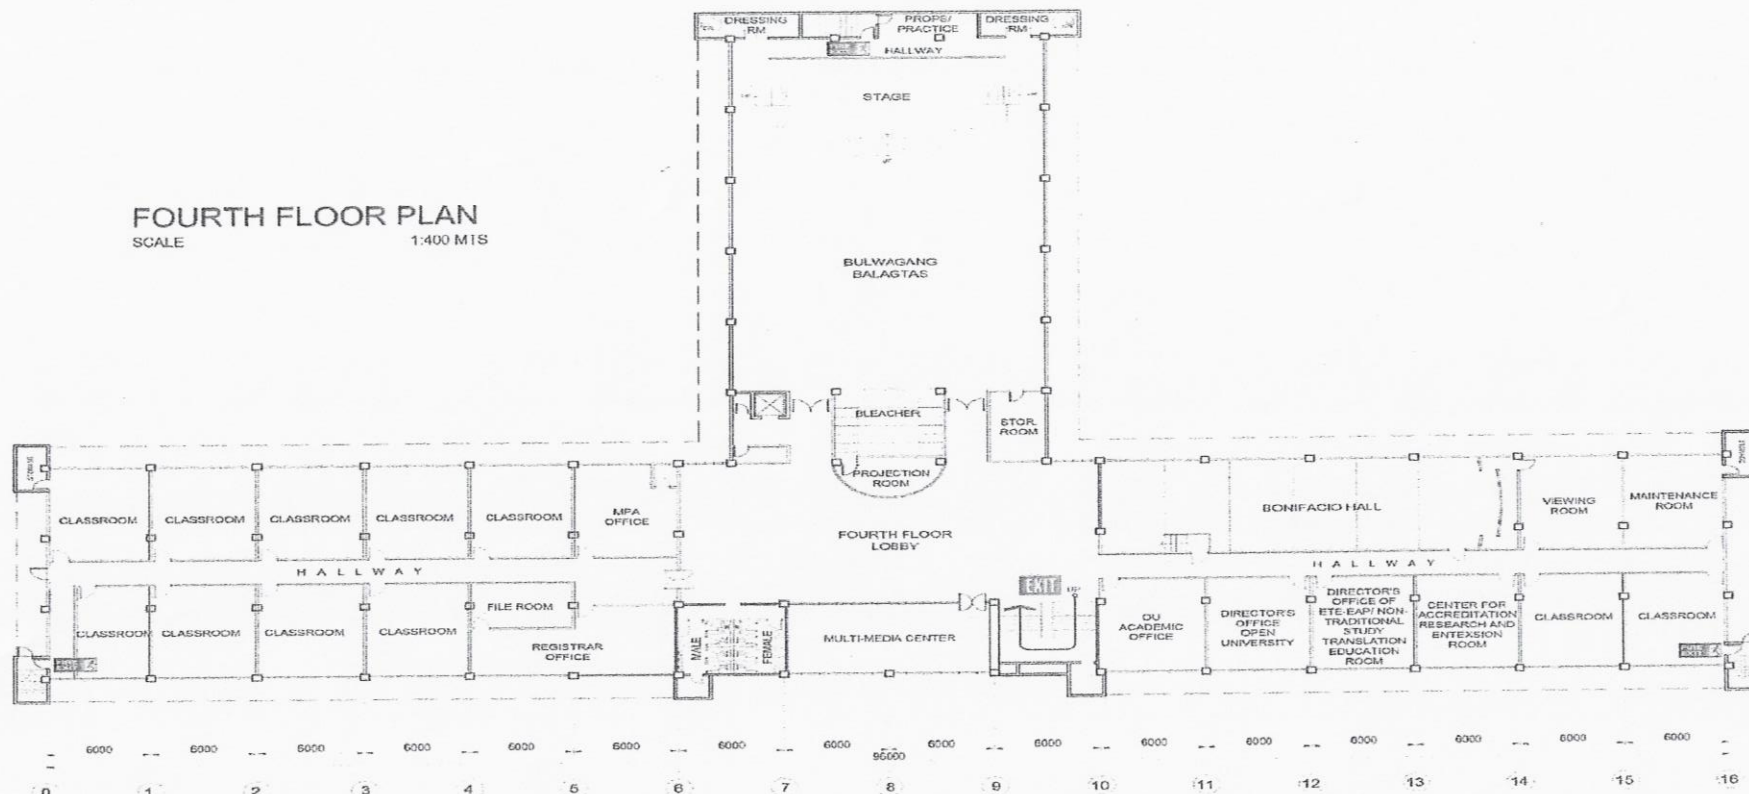


OWNER Republic of the Philippines POLYTECHNIC UNIVERSITY OF THE PHILIPPINES Sta. Mesa, Manila	PROJECT TITLE NINYO AQUINO LEARNING RESOURCE CENTER LOCATION: PUP MABINI CAMPUS, STA. MESA, MANILA	PREPARED BY AR./EDP. SHERWIN N. NIEVA DIRECTOR PHYSICAL PLANNING AND DEVELOPMENT OFFICE	SHEET CONTENTS AS SHOWN CADD BY: CCP DATE:	SHEET NO. A-4
--	--	---	--	-------------------------

(02) 8713 5968 | dcoe_chair@gmail.com
 RM322 CEA BLDG. NDC COMPOUND,
 ANONAS COR. PUREZA STREETS, STA. MESA, MANILA





POLYTECHNIC UNIVERSITY OF THE PHILIPPINES
COLLEGE OF ENGINEERING
COMPUTER ENGINEERING DEPARTMENT

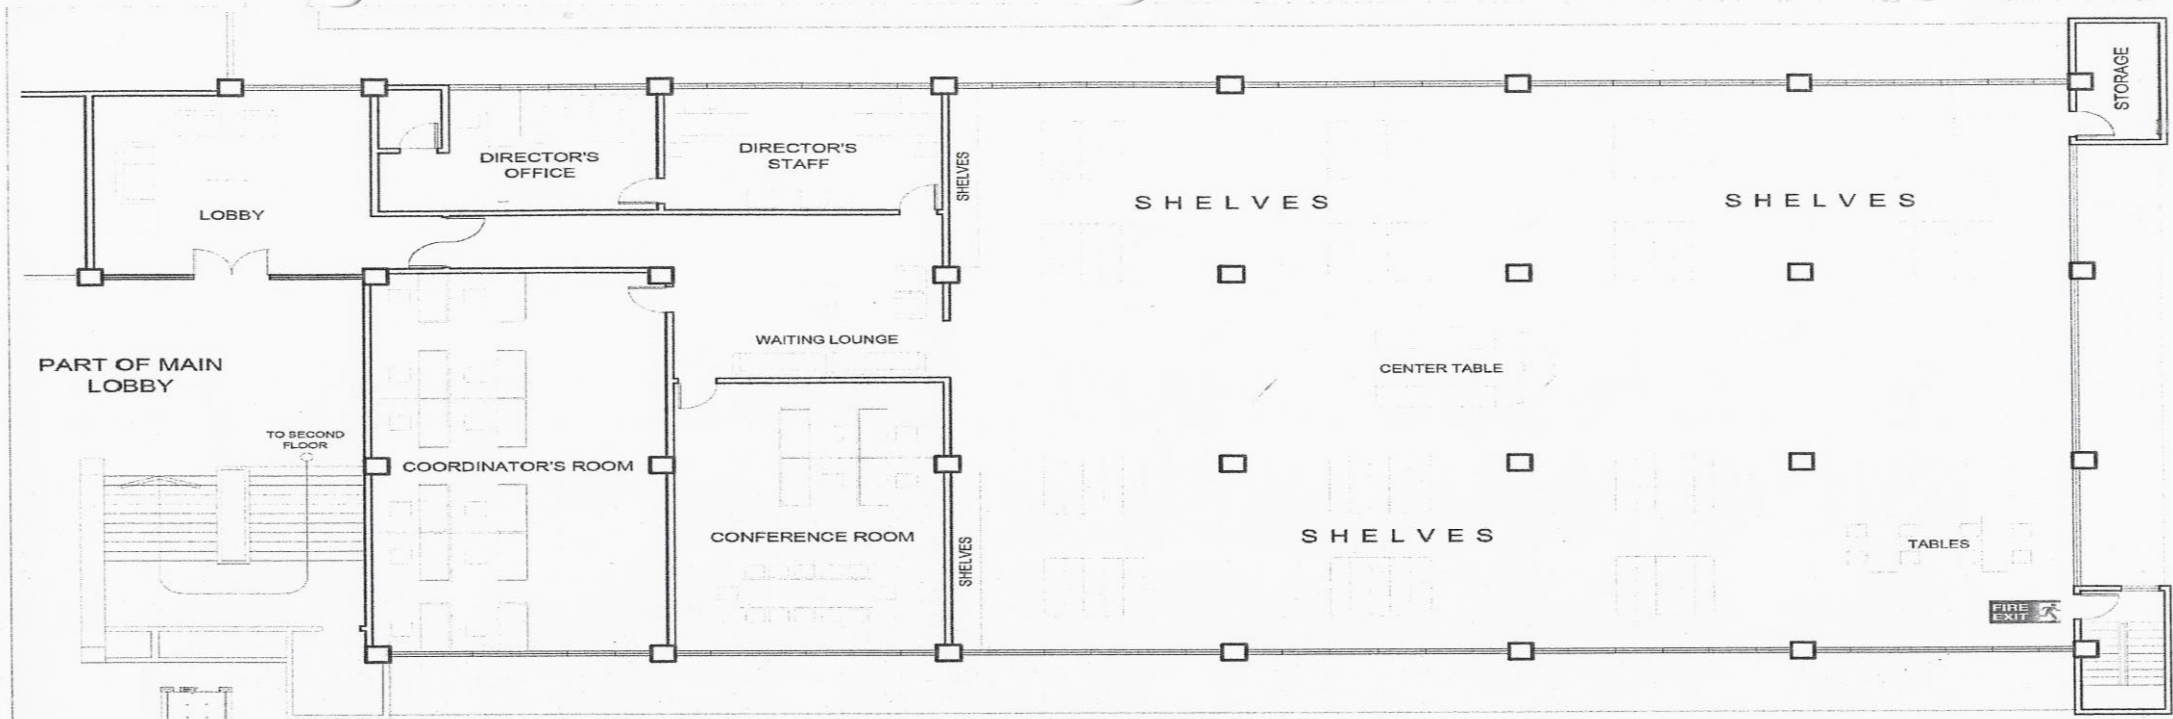

GROUND FLOOR PLAN
 SCALE 1:250 MTS


OWNER	PROJECT TITLE	PREPARED BY	SHEET CONTENTS	SHEET NO.
Republic of the Philippines POLYTECHNIC UNIVERSITY OF THE PHILIPPINES Sta. Mesa, Manila	QUALITY ASSURANCE/ ACCREDITATION CENTER <small>LOCATION: GRND. FLR. NINYO AQUINO LEARNING RESOURCE CENTER, MABINI CAMPUS, STA. MESA, MANILA</small>	<i>AR/EnP. BHERWIN N. NIEVA</i> DIRECTOR PHYSICAL PLANNING AND DEVELOPMENT OFFICE	AS SHOWN CADD BY: CCF DATE:	A-1

(02) 8713 5968 | dcoe_chair@gmail.com
 RM322 CEA BLDG. NDC COMPOUND,
 ANONAS COR. PUREZA STREETS, STA. MESA, MANILA





**POLYTECHNIC UNIVERSITY OF THE PHILIPPINES
COLLEGE OF ENGINEERING
COMPUTER ENGINEERING DEPARTMENT**

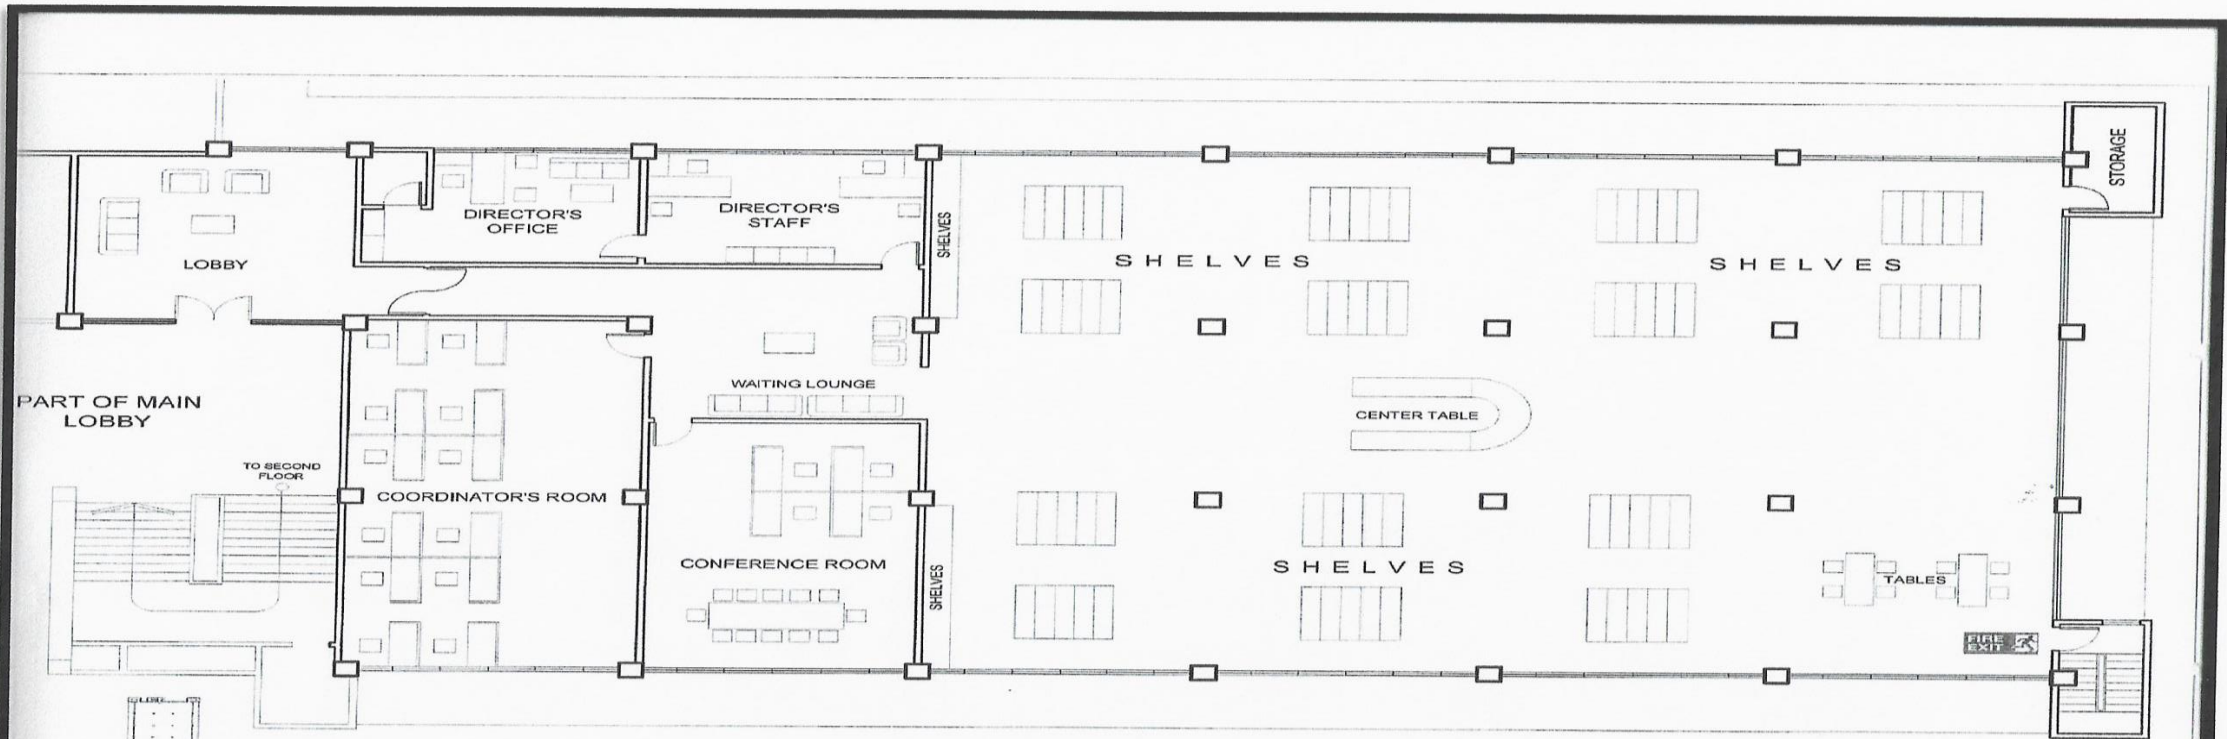

GROUND FLOOR PLAN
SCALE 1:250 MTS

N E R Republic of the Philippines POLYTECHNIC UNIVERSITY OF THE PHILIPPINES Sta. Mesa, Manila	PROJECT TITLE QUALITY ASSURANCE/ ACCREDITATION CENTER	PREPARED BY ARCE SHERWIN N. NIEVA DIRECTOR PHYSICAL PLANNING AND DEVELOPMENT OFFICE	SHEET CONTENTS AS SHOWN CADD BY: CCP DATE:	SHEET NO. A-1
	LOCATION: BRND. FUR. HINDY AGUIÑO LEARNING RESOURCE CENTER, MABINI CAMPUS, STA. MESA, MANILA			

(02) 8713 5968 | dcoe_chair@gmail.com
 RM322 CEA BLDG. NDC COMPOUND,
 ANONAS COR. PUREZA STREETS, STA. MESA, MANILA



ISO 9001:2015 CERTIFIED
 CERTIFICATE NUMBER: SCP0004130



POLYTECHNIC UNIVERSITY OF THE PHILIPPINES
COLLEGE OF ENGINEERING
COMPUTER ENGINEERING DEPARTMENT

Quality Assurance Center Floor Plan

(02) 8713 5968 | dcoe_chair@gmail.com
RM322 CEA BLDG. NDC COMPOUND,
ANONAS COR. PUREZA STREETS, STA. MESA, MANILA



ISO 9001:2015 CERTIFIED
CERTIFICATE NUMBER: SCP0004130